


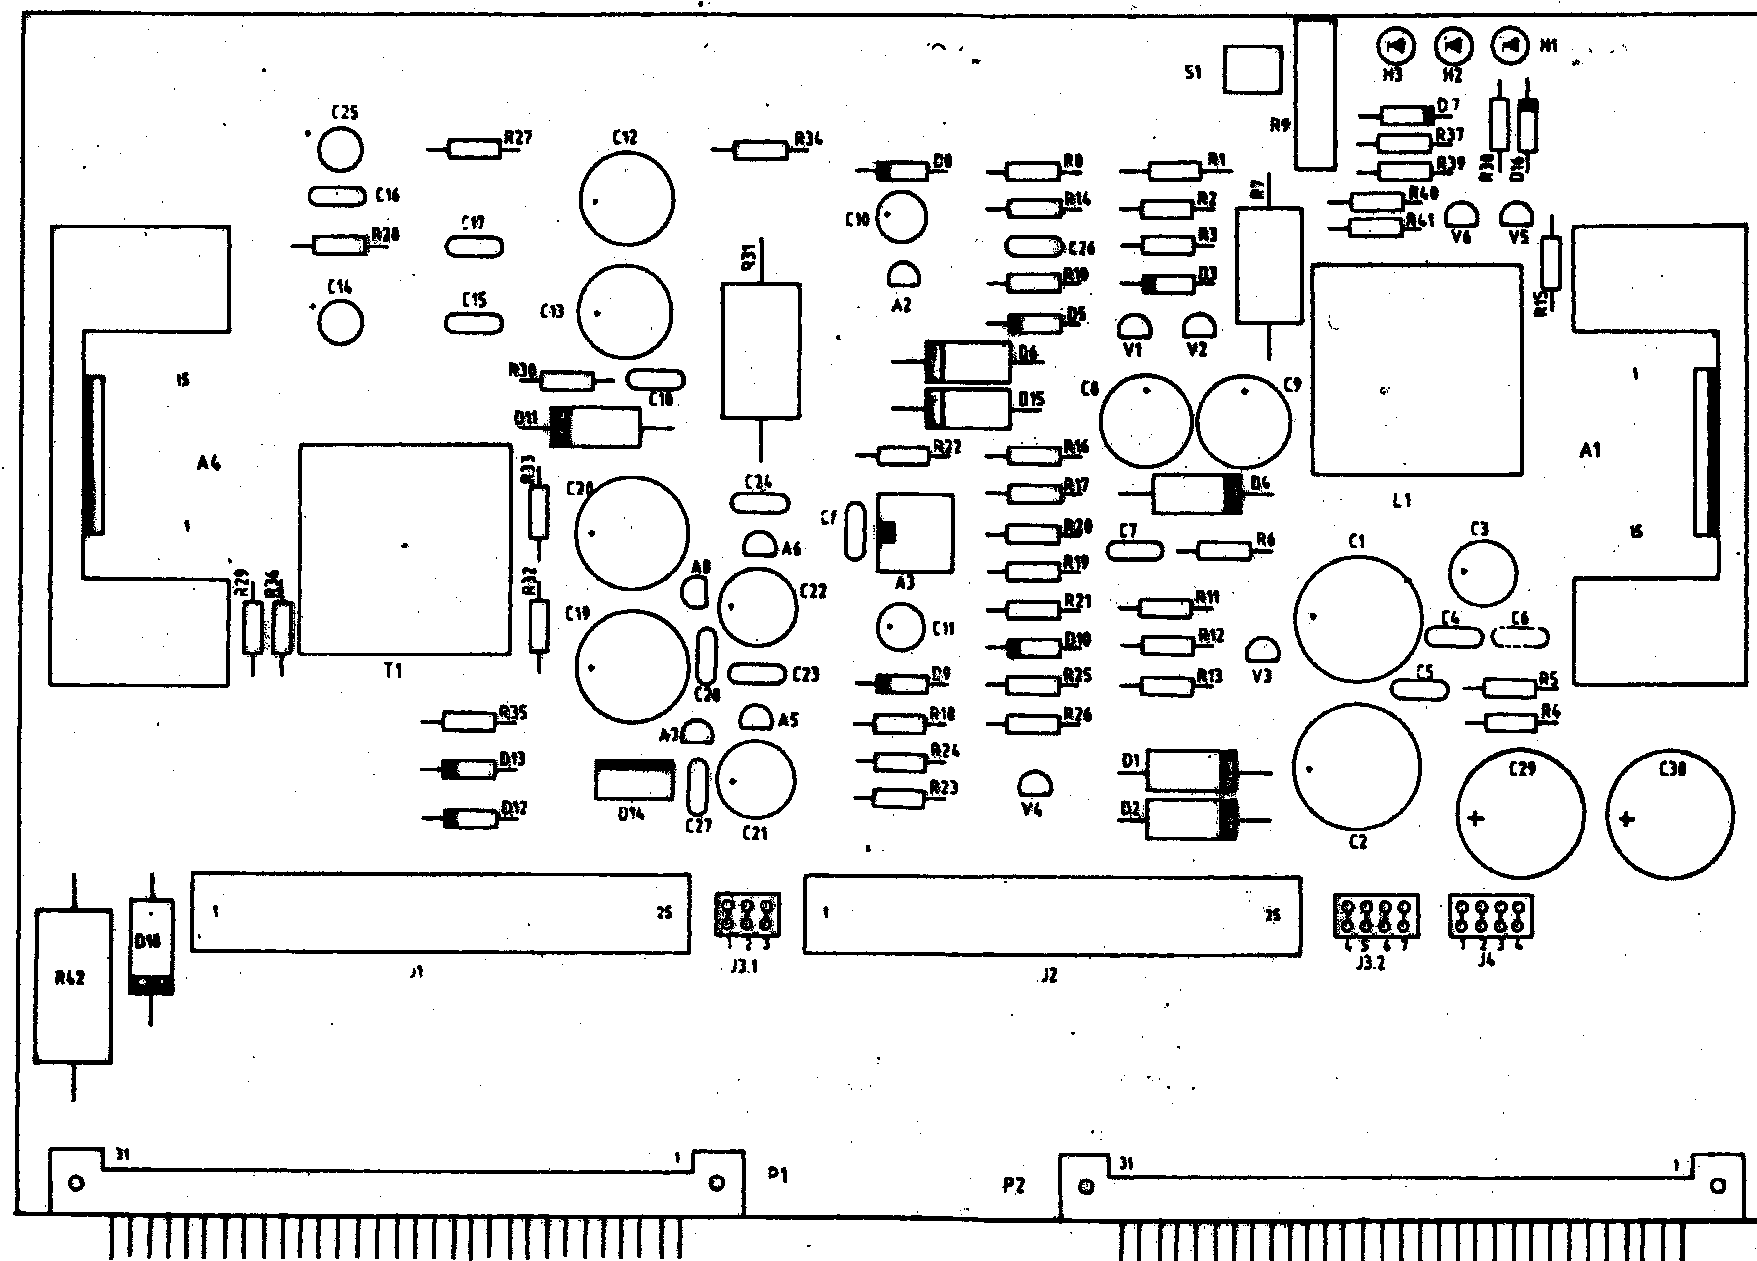

NOTA : — PONTICELLO "J1" DA MONTARE PER
CONNESSIONE A SCHEDA 40

— PONTICELLO "J2" DA MONTARE PER
CONNESSIONE A SCHEDA 24 OPPURE 48
OPPURE 70 (STANDARD)

IMPORTANTE :
CACCIALANZA & C. S.p.A. si riserva il diritto di modificare senza preavviso le informazioni
contenute su questa scheda con il proposito di apportare miglioramenti alla produzione

IMPORTANT :
CACCIALANZA & C. S.p.A. reserves the right to change or modify without previous notice any data
or specification due to changes or modification in order to improve the products presented

0	28.06.99	EMESSO	CA	CA	
Rev.	Date	Description	Drawn	Checked	Approved
CACCIALANZA & C. S.p.A. ANTINCENDIO SICUREZZA ANTINQUINAMENTO SEGRATE (MILANO) - ITALY		Client / Project			
		Title			
Drawn	28.06.99	CA	SCHEDA MOT67 PER LKS6 VISTA COMPONENTI		
Checked	28.06.99	CA			
Approved					
Code	4640016709	Sys.	Size	Scale	Dwg nr.
			A3	1:1	46196706
THIS DRAWING IS THE PROPERTY OF CACCIALANZA & C. S.p.A. AND IS NOT TO BE REPRODUCED OR USED TO FURNISH ANY INFORMATION FOR MAKING OF DRAWINGS OR APPARATUS EXCEPT WHERE PROVIDED FOR BY AGREEMENT WITH SAID COMPANY					
			Rev.	Sheet	
			0	1	
				of	1